


X = 2917534.661
 Y = 275159.459
 Z = 101.840

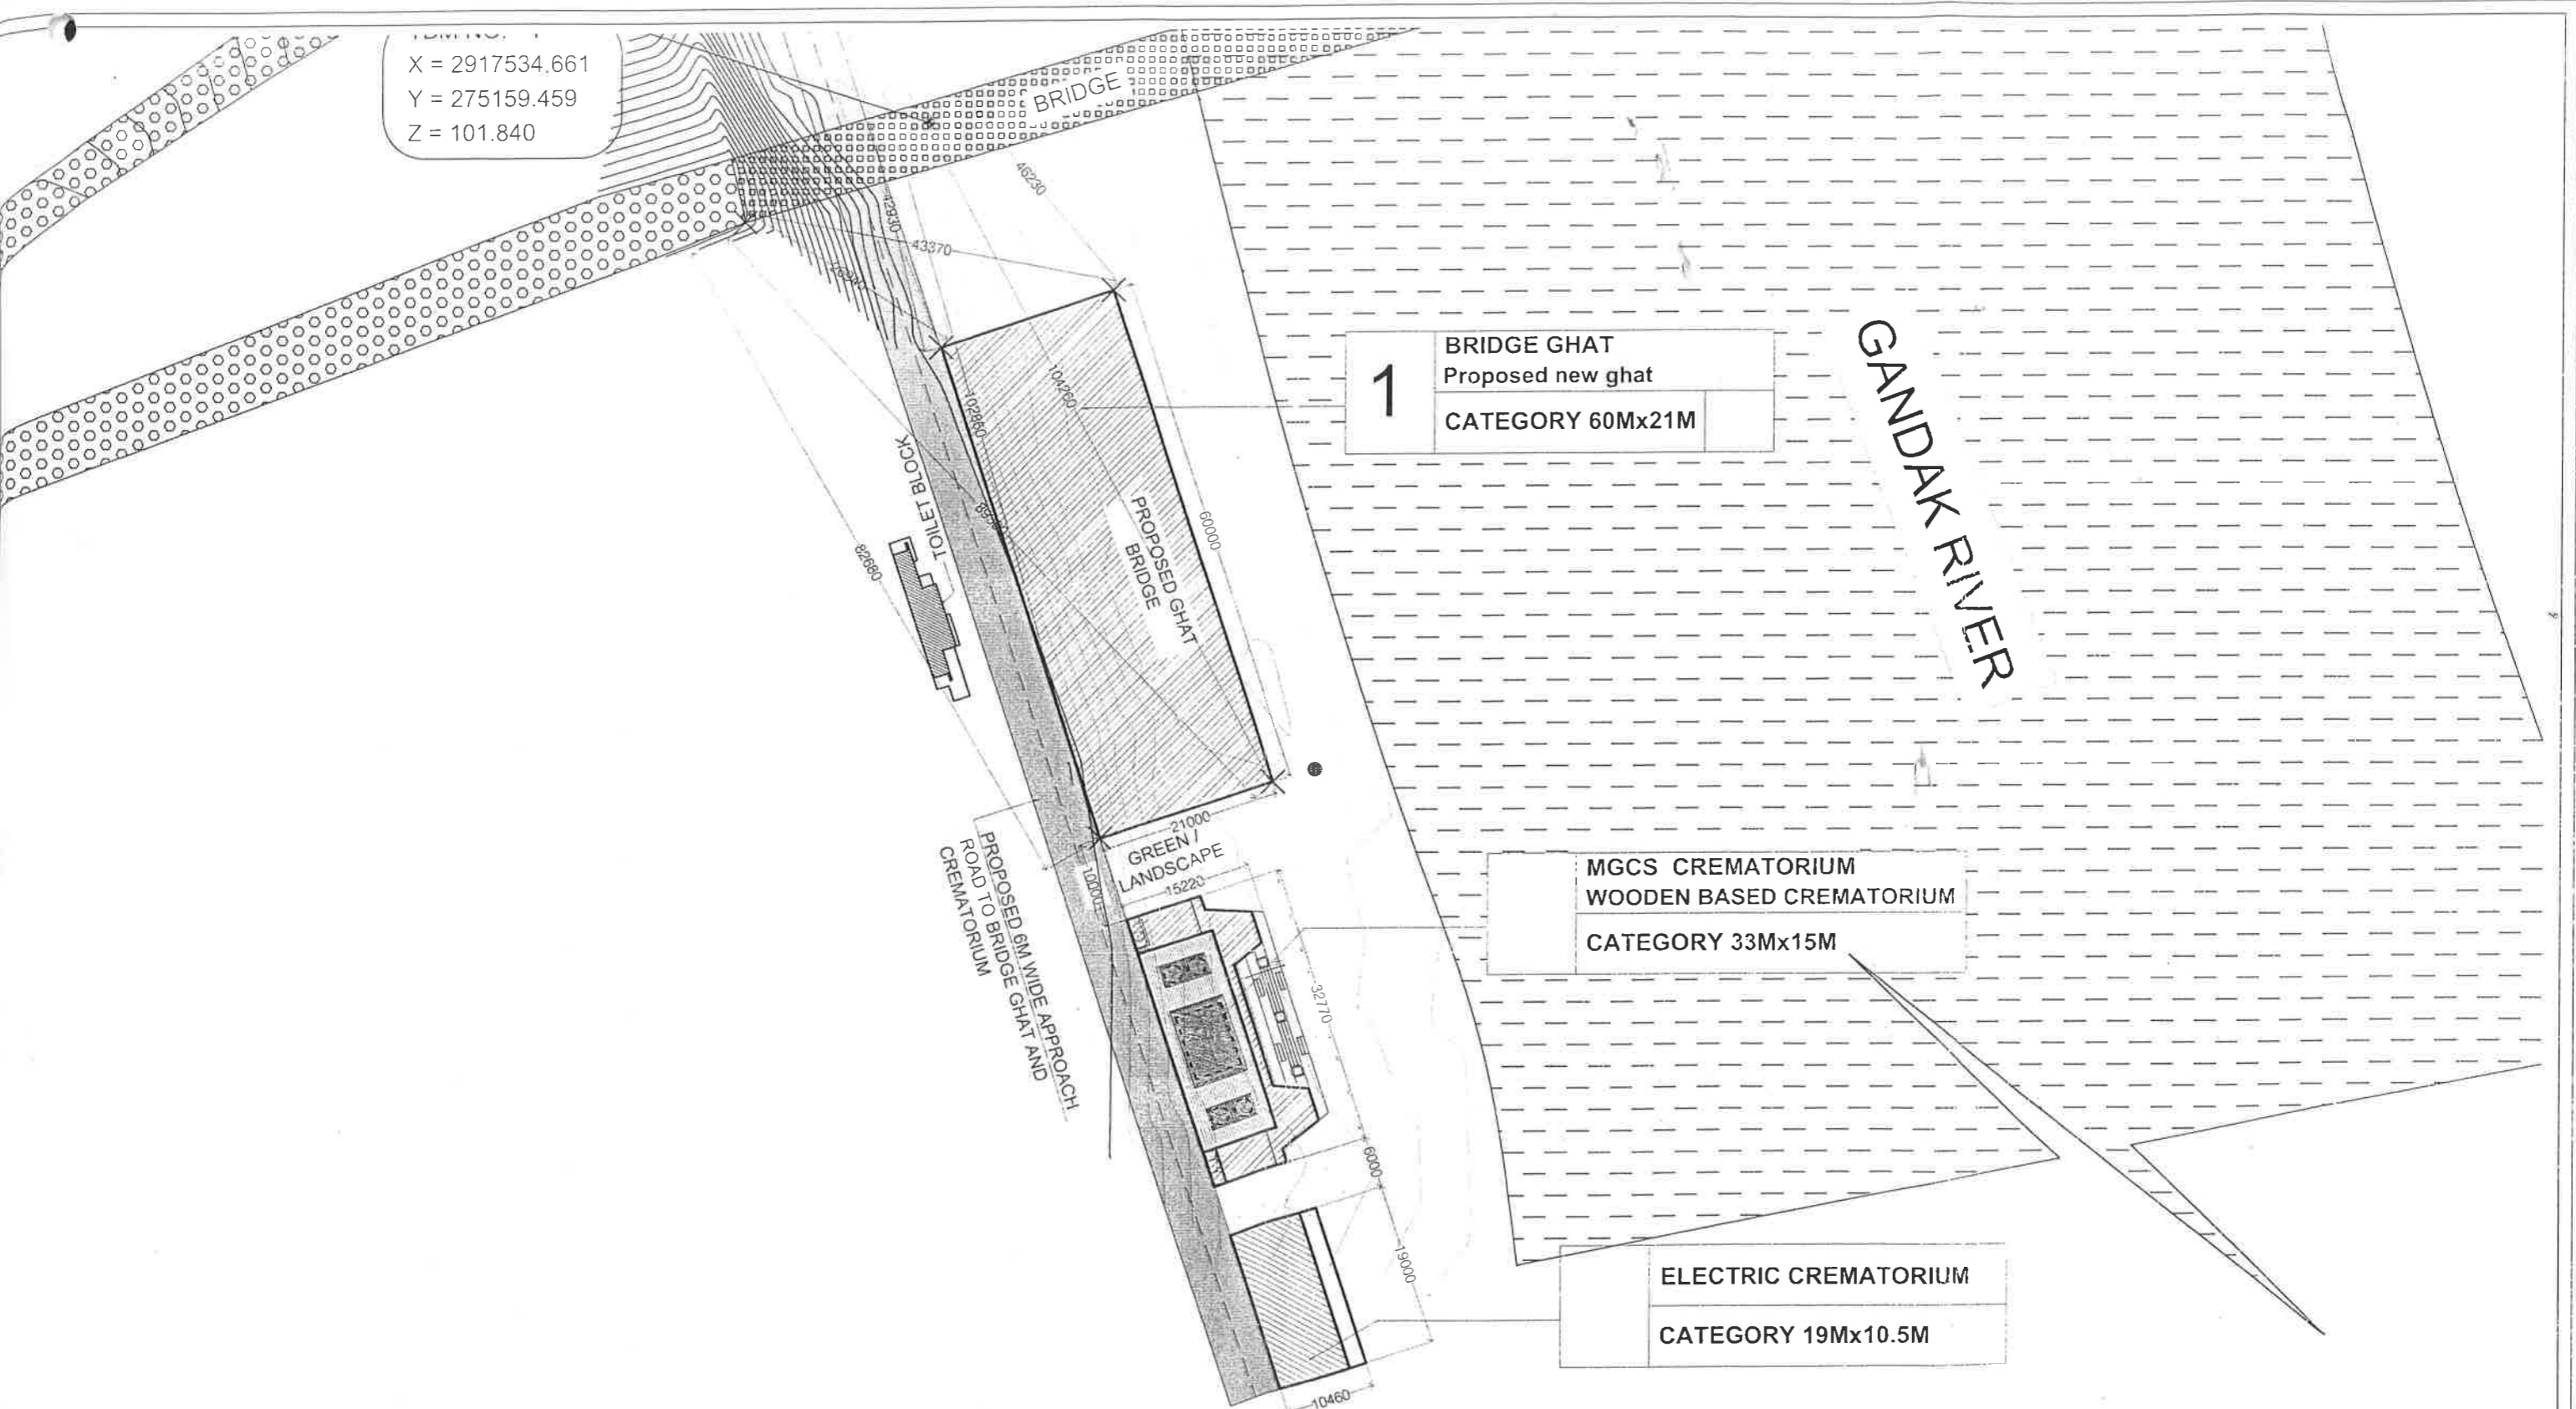

1
 BRIDGE GHAT
 Proposed new ghat
 CATEGORY 60Mx21M

MGCS CREMATORIUM
 WOODEN BASED CREMATORIUM
 CATEGORY 33Mx15M

ELECTRIC CREMATORIUM
 CATEGORY 19Mx10.5M


GANDAK RIVER

SET OUT PLAN

GOPALGANJ- MCGS CREMATORIUM (33.0M X 15.0M) & ELECTRIC CREMATORIUM (19MX10.5M)

GOPALGANJ	
CREMATORIUM	
SHEET NO	SHEET NO
CRE.G/GA/A-201/R1	1

BHAR URBAN INFRASTRUCTURE DEVELOPMENT CORPORATION LTD. (BUIDCO)	NATIONAL MISSION FOR CLEAN GANGA	PROJECT NAMAMI GANGE PROGRAM, BIHAR TOWN: GOPALGANJ	CONSULTANTS sen & lall consultants pvt. ltd. architects , engineers urban planners, Pains - 800001 ph -0612- 2320946 ,email: slcpt_consultant@sify.com All Dimensions are in Meters.	REVISION NO. DATE DESCRIPTION R1 14.06.2018 ELECTRIC CREMATORIUM		DEALT DRAWN DATE SCALE	ABHISHEK MANDLWAR ABHISHEK MANDLWAR 28.07.2018 1:750(N=3)	SHEET TITLE: TENDER DRAWING SHEET NAME: CREMATORIUM SHEET NAME: SETOUT_PLAN
				SHEET REVISION RECORD				

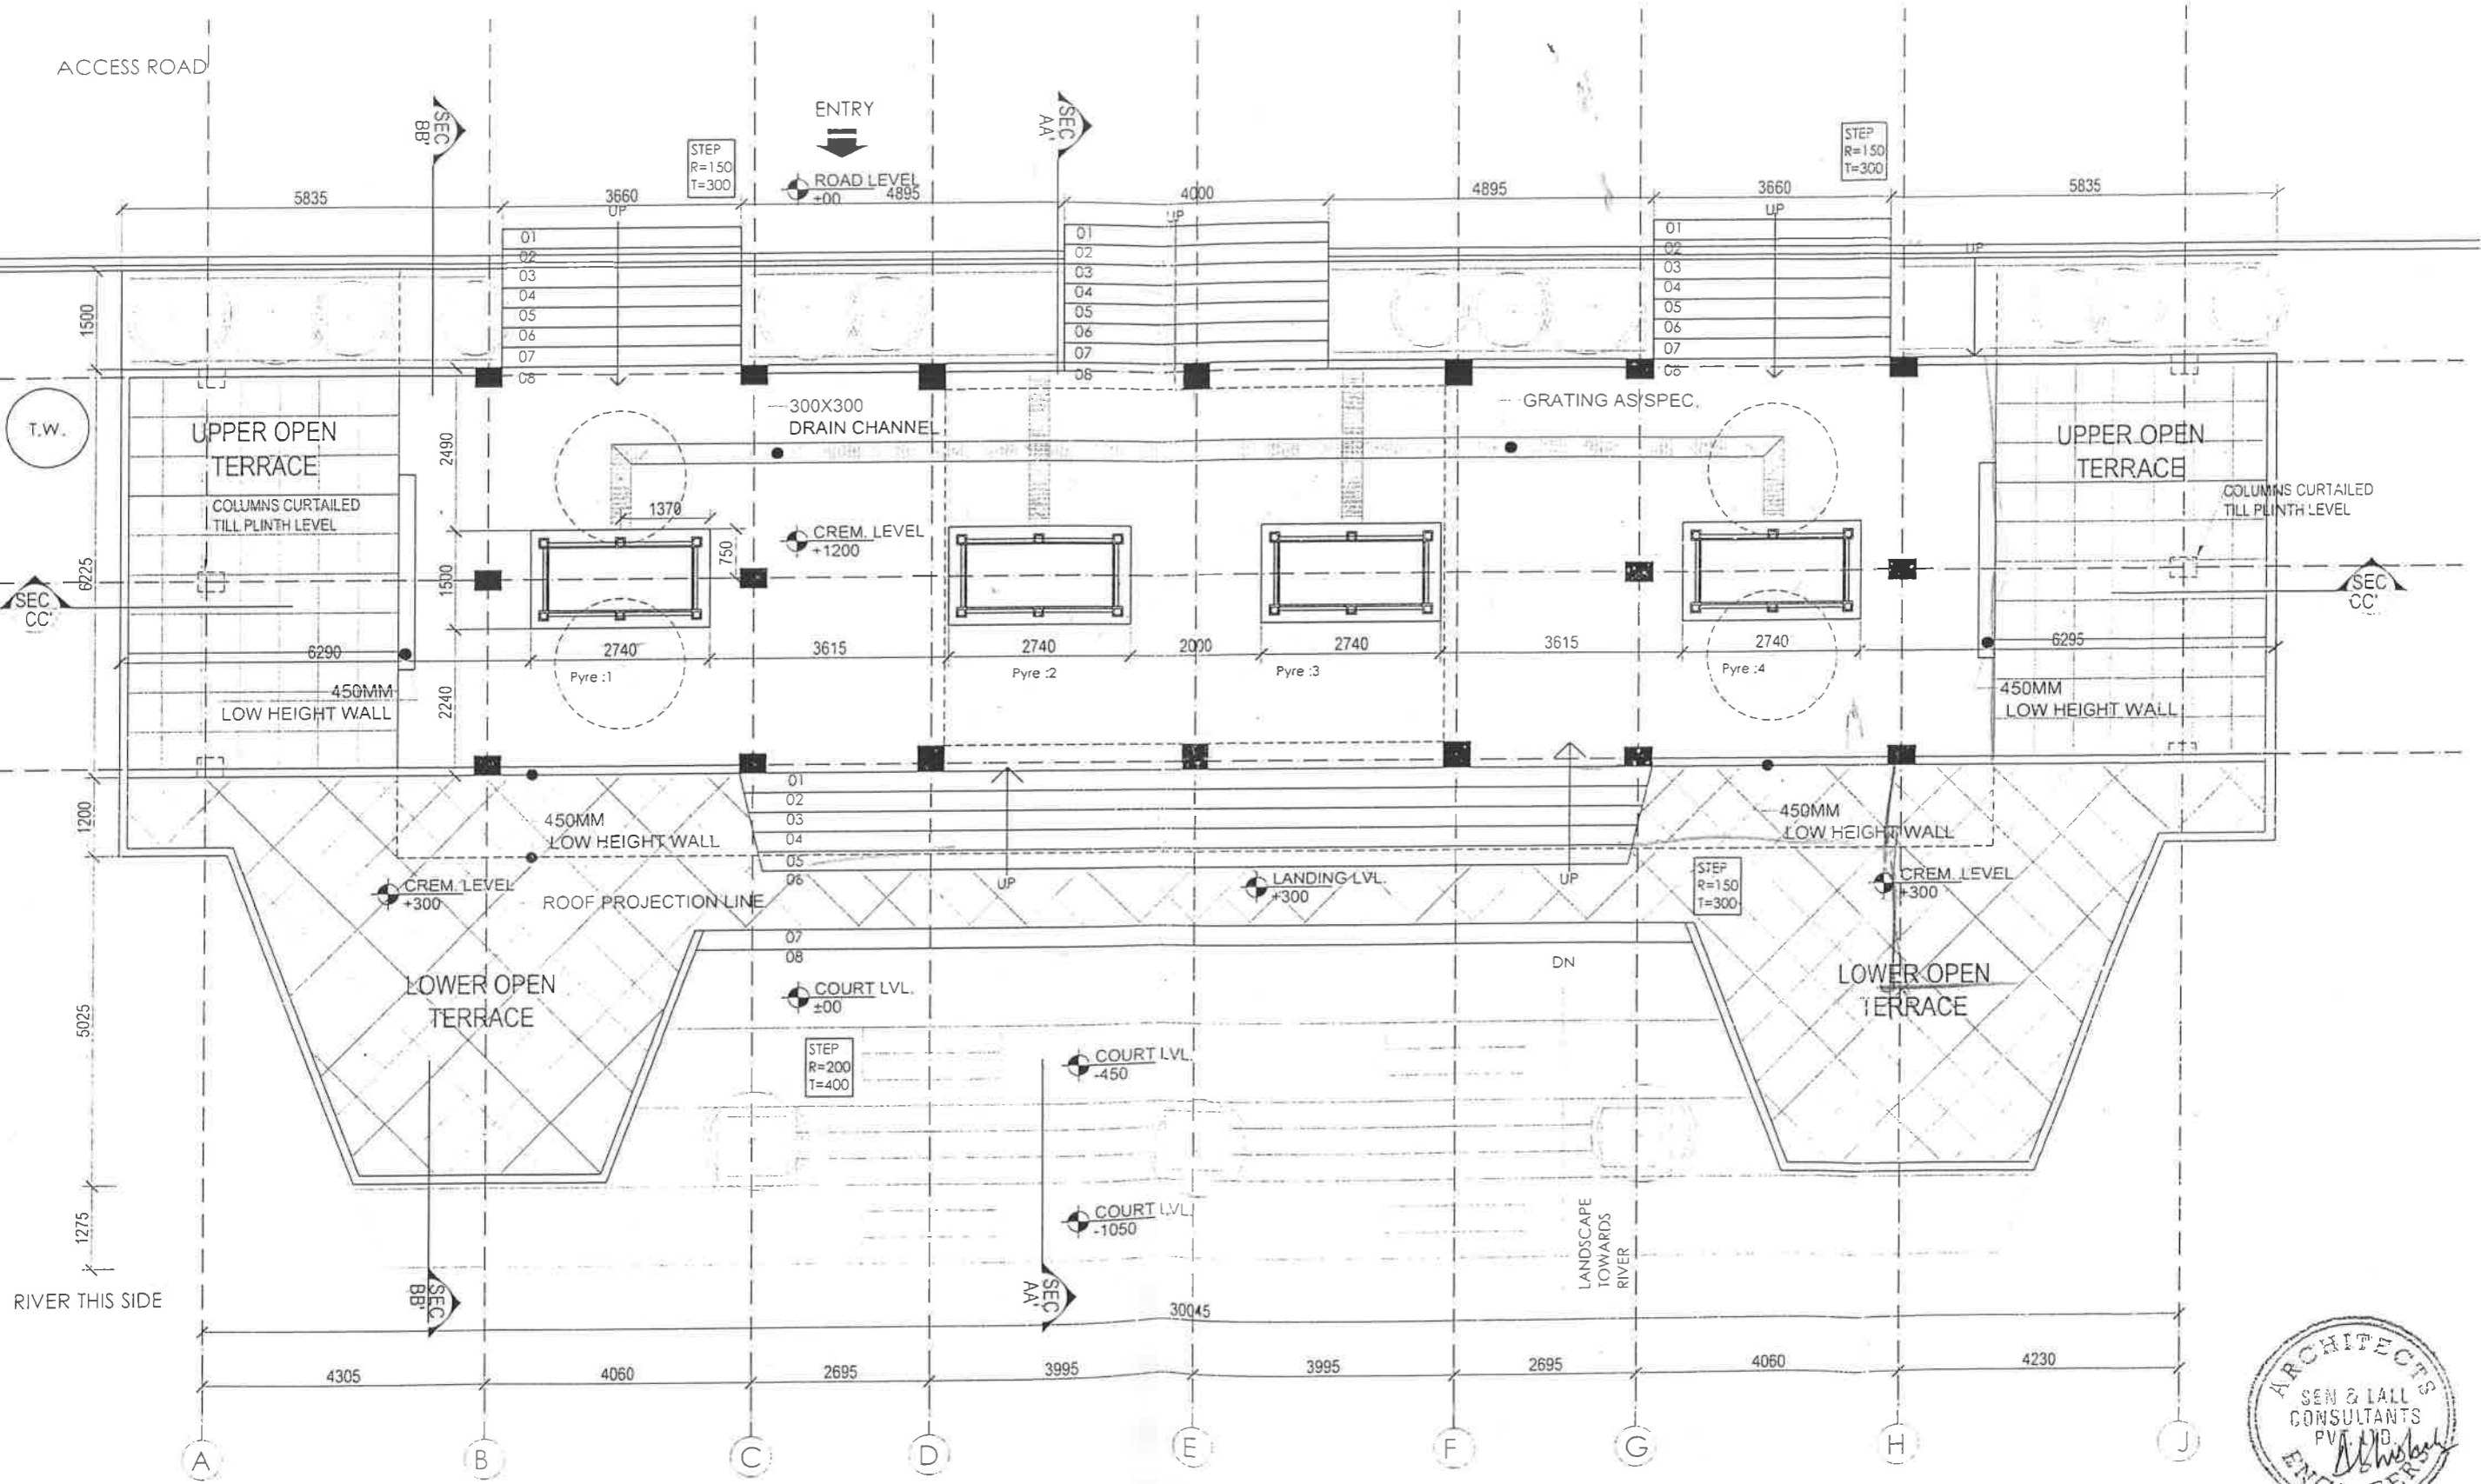

PLAN




BIHAR URBAN INFRASTRUCTURE DEVELOPMENT CORPORATION, LTD. NATIONAL MISSION FOR CLEAN CANALS	PROJECT NAMAMI GANGE PROGRAM, BIHAR TOWN: GOPALGANJ	DRAWING NO. GCH/R-0/A-101	SHEET NO. 01
		CLIENT ABHISHEK MANDILWAR	DATE 28.07.2018
PREPARED BY sen & lall consultants pvt. ltd.	CHECKED BY ABHISHEK MANDILWAR	SCALE 1:500	PROJECT NAME CREMATORIUM
DATE 28.07.2018	PROJECT NO. RO Q	DRAWING NO. GCH/R-0/A-101	SHEET NO. 01

GANDAK RIVER

1 BRIDGE GHAT
Proposed new ghat
CATEGORY 60Mx21M

CREMATORIUM
Proposed new CREMATORIUM
CATEGORY 33Mx15M

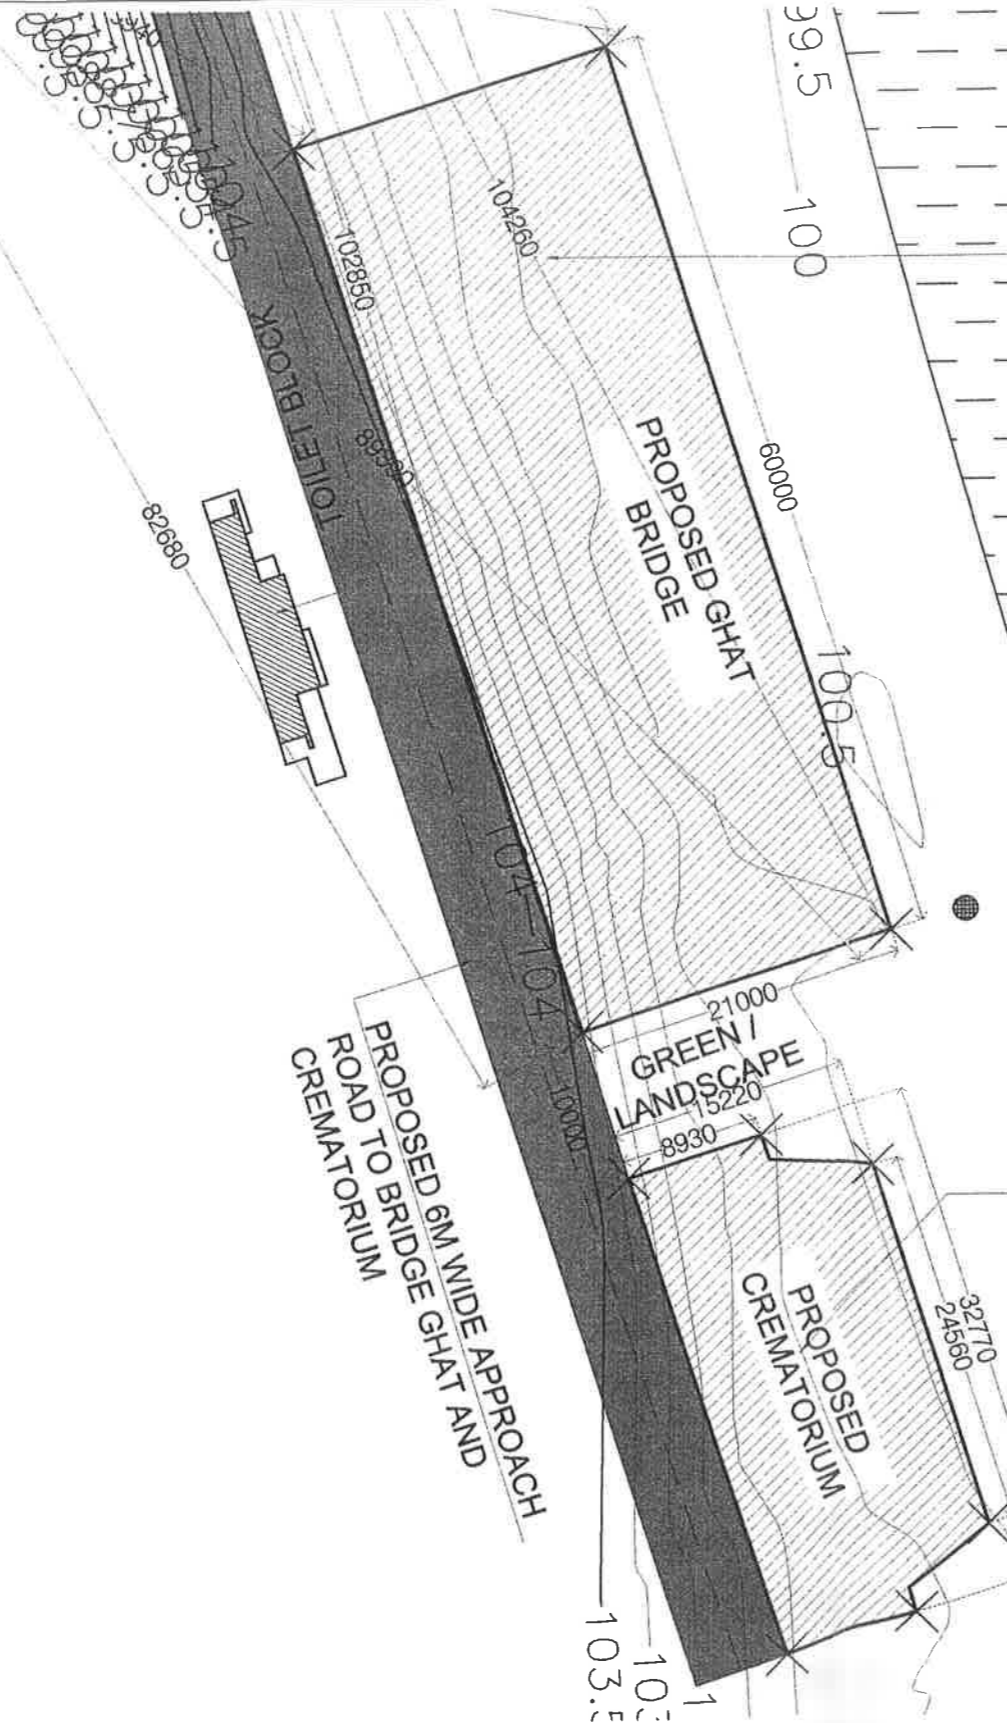

SET OUT PLAN

GOPALGANJ- CREMATORIUM (33.0M X 15.0M)

CREMATORIUM SIZE	GOPALGANJ
33M X 15M	CREMATORIUM
SHEET TITLE TENDER DRAWING	SHEET NO
GHAT NAME CREMATORIUM	CRE.G/GAVA-201
GHAT NO	1

CLIENTS
BIHAR URBAN INFRASTRUCTURE
DEVELOPMENT CORPORATION LTD
(BUIDCO)

PROJECT
NATIONAL MISSION FOR CLEAN GANGA

PROJECT
NAMAMI GANGE PROGRAM, BIHAR
TOWN: GOPALGANJ


CONSULTANTS
sen & lall consultants pvt. ltd.
architects engineers urban planners Patna - 800001
ph.-0612- 2320946, email: slcpt_consultant@slfy.com
All Dimensions are in Meters

NO.	DATE	REVISION	CHKD.


SHEET REVISION RECORD

REVISION
R0

 
DEALT
REHMAN LALL
DRAWN
ADHISHYK MANDLWAP
DATE
29.07.2015
SCALE
1:500(A3)




Authorised person shall check the drawing and sign the name and date.

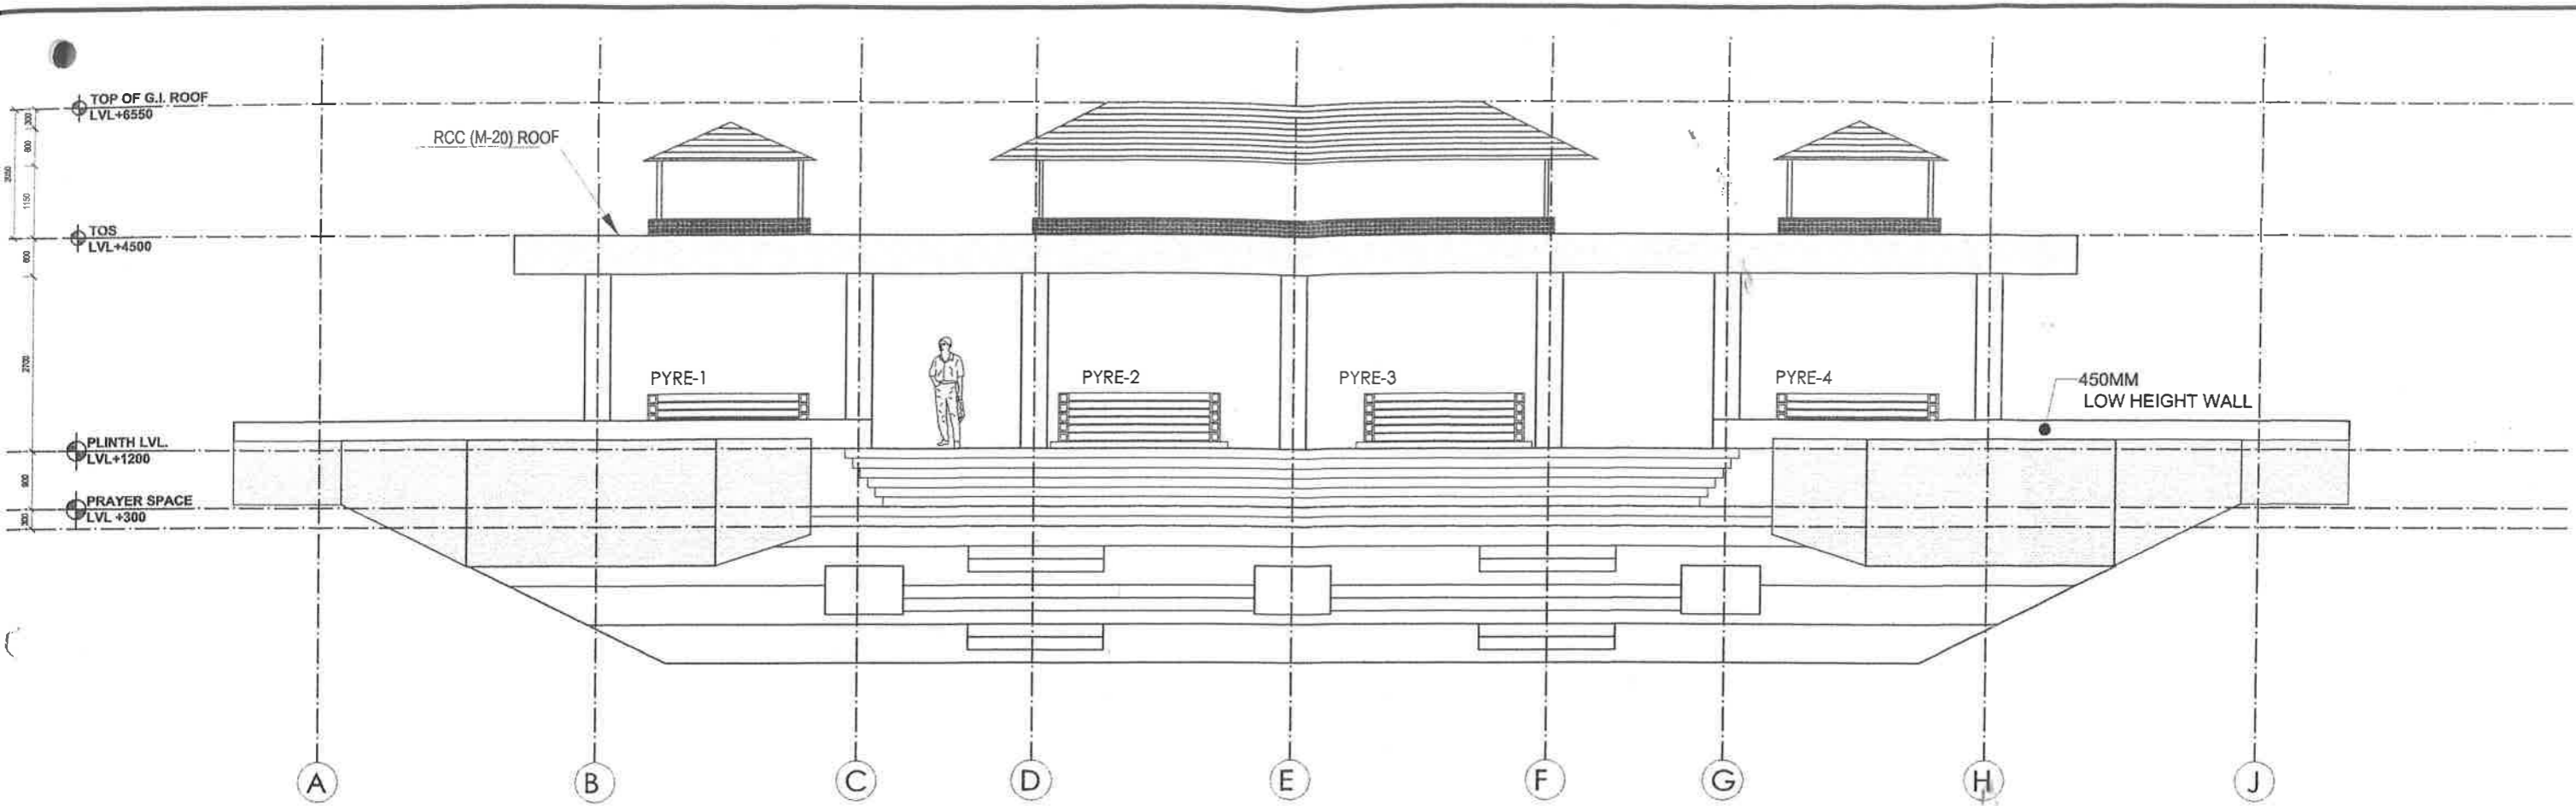

ELEVATION

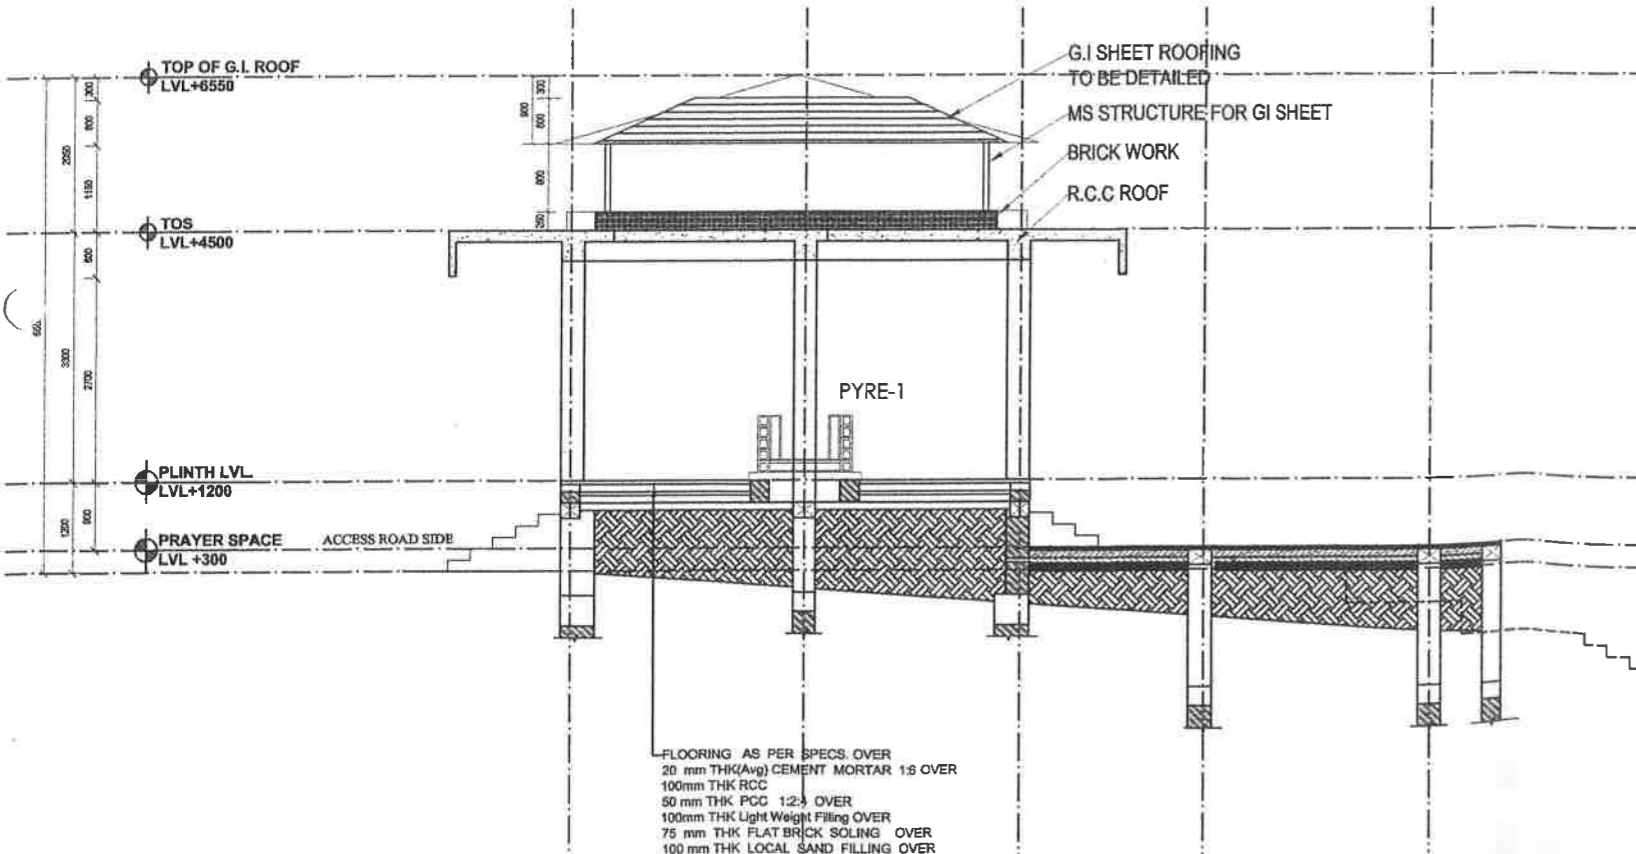

SECTION BB'

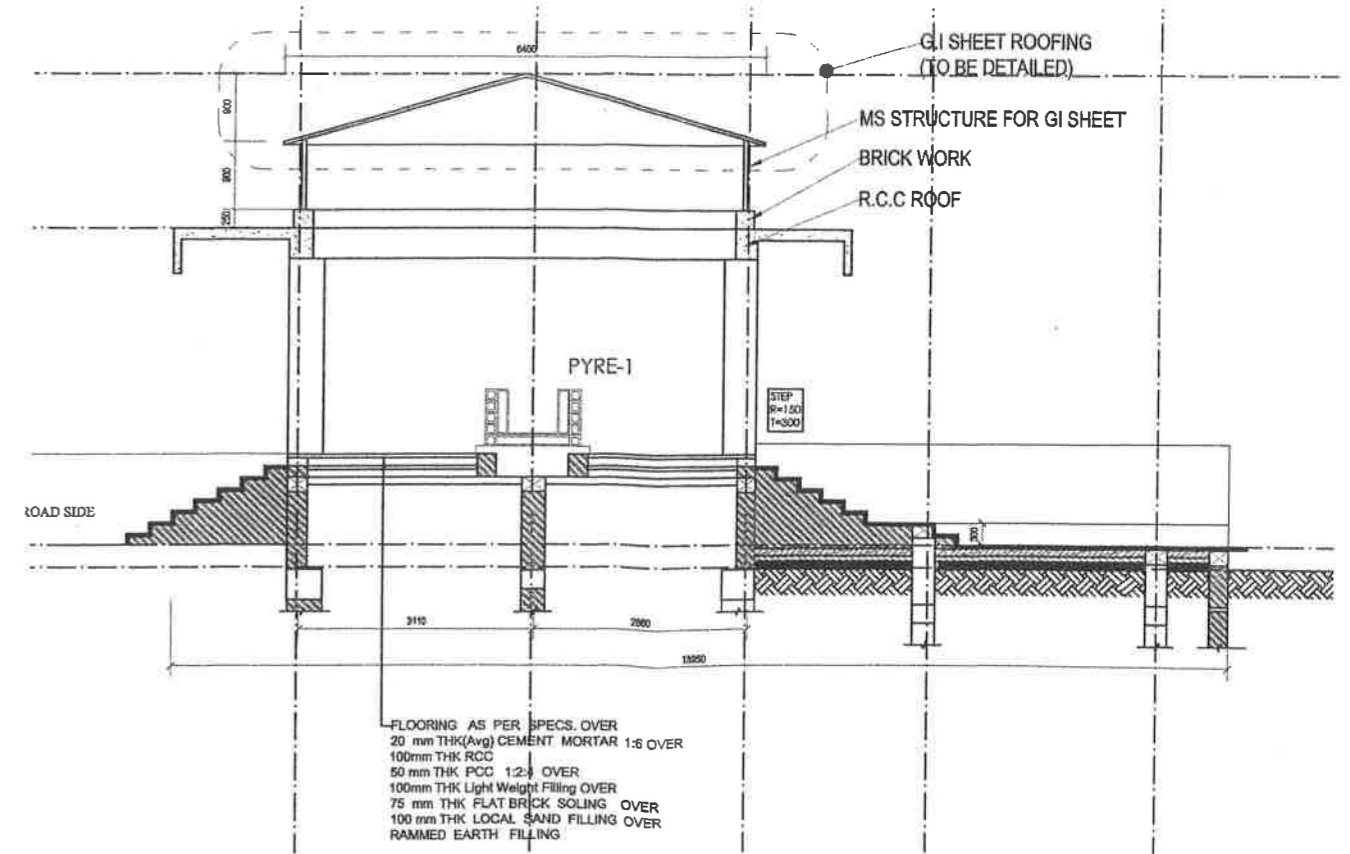


SECTION AA'

BHAR URBAN INFRASTRUCTURE DEVELOPMENT CORPORATION LTD. (BUIDCO)	NATIONAL MISSION FOR CLEAN GANGA	PROJECT: NAMAMI GANGE PROGRAM, BIHAR TOWN: GOPALGANJ	CONSULTANT: sen & lall consultants pvt. ltd. architects, engineers, urban planners, interior designers ph: +91 22 232946, email: slcp_consultants@yahoo.com All Dimensions are in Millimeters.	REVISION:	REVISION:	NORTH:	SEAL:	NISHANT	SHEET TITLE: CREMATORIUM	SHEET NO.:
				NO.	DATE: 29.07.2019	DRAWN: ABHISHEK	GCH/R-0/A-301	03		
				SHEET REVISION RECORD:	RO	SCALE: VARIES	DWG NAME: SECTIONS AND ELEVATION / RO			


DOOR-WINDOW SCHEDULE

S.NO.	TYPES	WIDTH	HEIGHT	SILL	LINTEL
1	D	900	2150	00	2150
2	RS	2100	2150	00	2400
3	CG	2400	2150	00	2150
4	W	1050	1100	900	2150

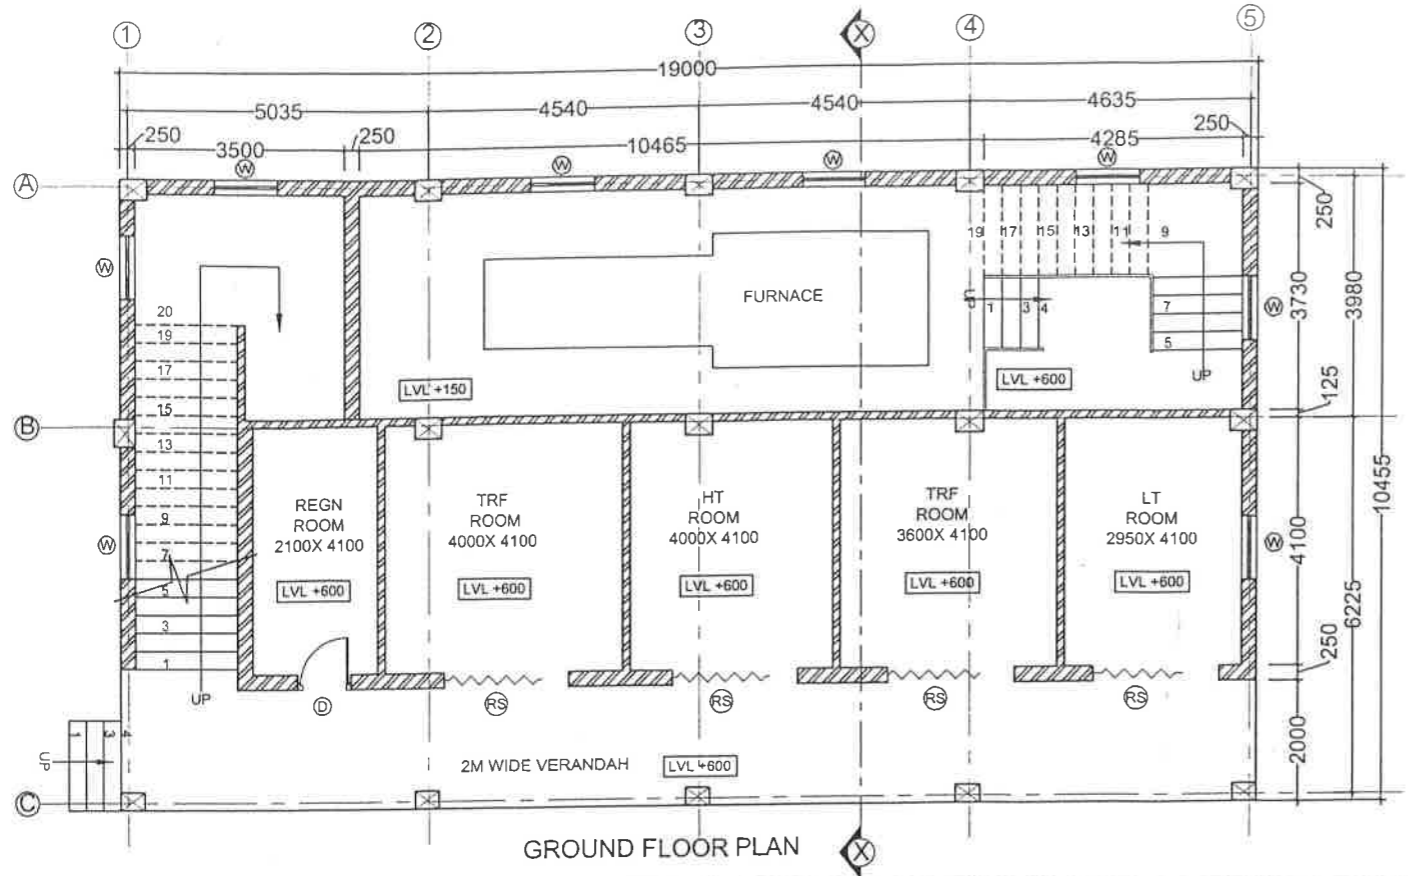


GROUND FLOOR PLAN

SCALE -1:125

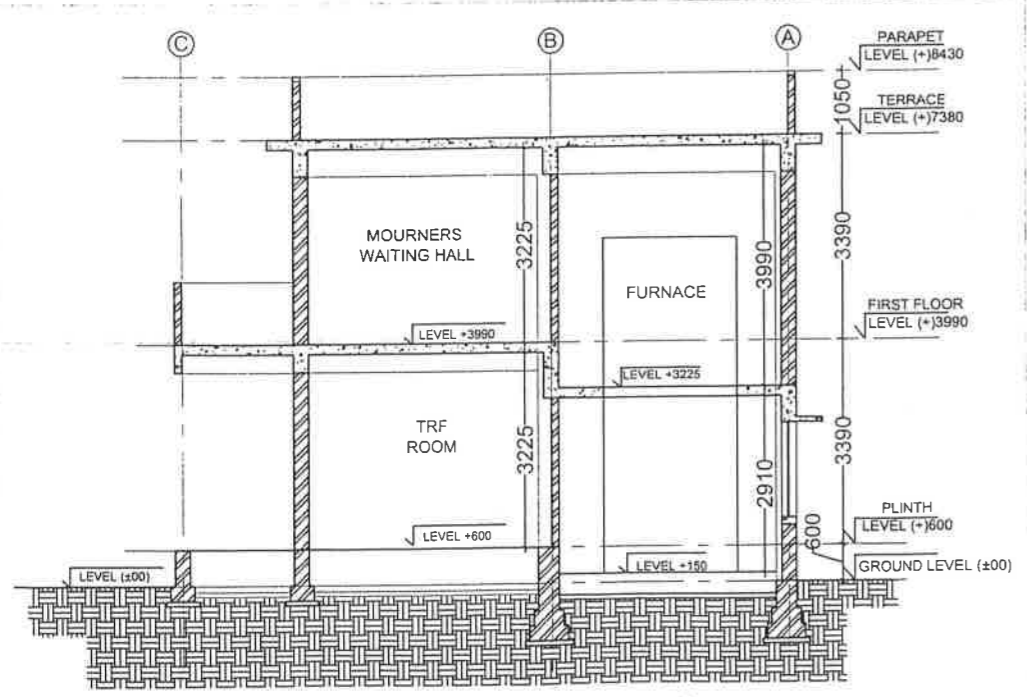

SECTION-XX

SCALE -1:125

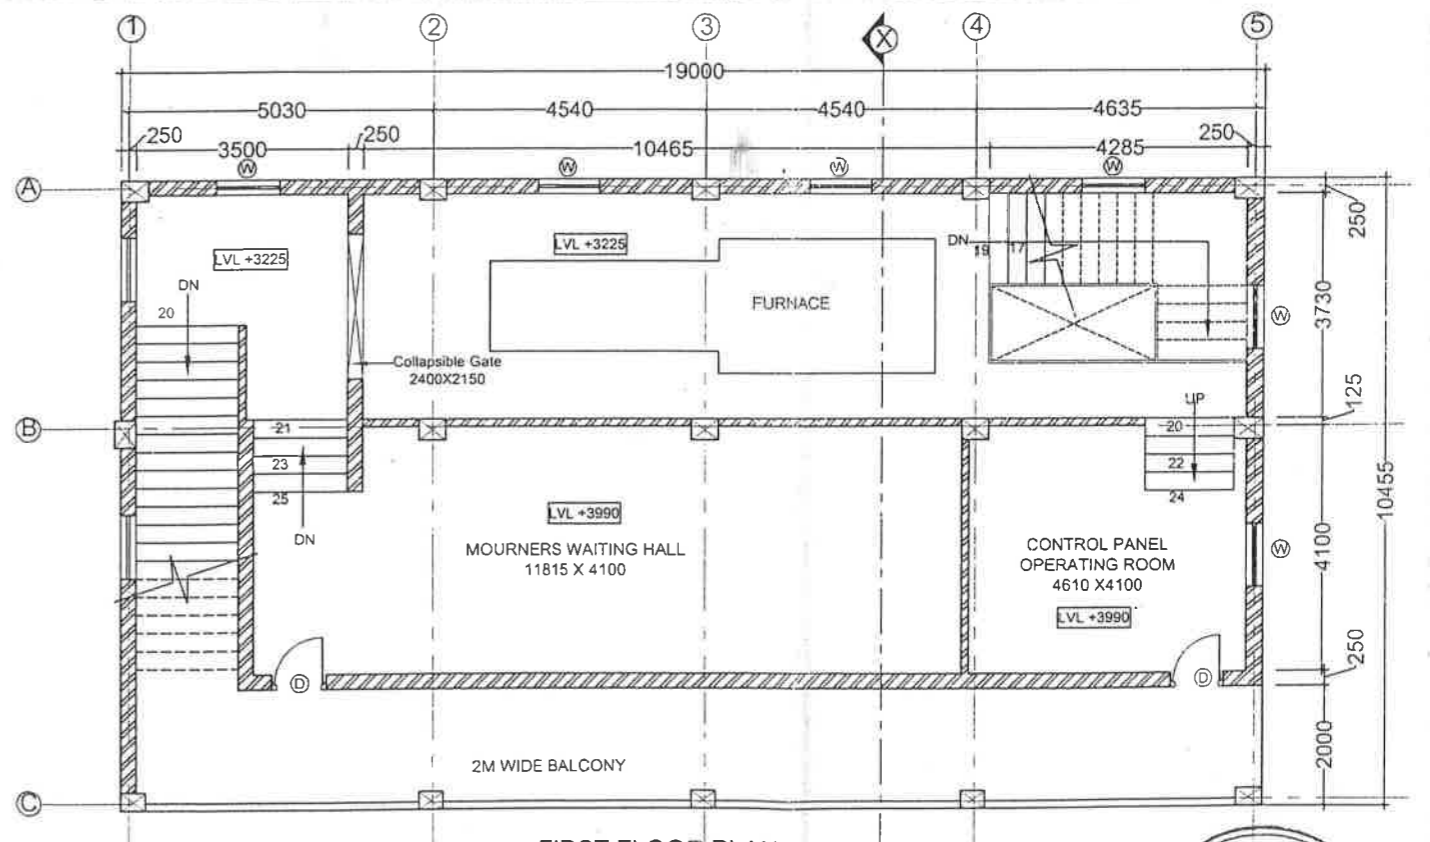

FIRST FLOOR PLAN

SCALE -1:125

PLAN & SECTION



CLIENTS BIHAR URBAN INFRASTRUCTURE DEVELOPMENT CORPORATION LTD. (BUIDCC)	PROJECT NATIONAL MISSION FOR CLEAN GANGA DEVELOPMENT OF GHAT GOPALGANJ, BIHAR	CONSULTANTS sen & ill consultants pvt. ltd. architects, engineers, urban planners, Patna - 800001 ph: 0612- 2320946, email: aicpl_consultants@gmail.com	REVISIONS NO. DATE BY	REVISIONS NO. DATE BY	DRAWN: ANIL DATE: 08.06.2019 SCALE: 1:125(A3)	SHEET NO: ELETIC CREMATORIUM PLAN + RF	SHEET NO: GCH/R-01A-101	01
					PROJECT NO: R0	PROJECT NO: ELETIC CREMATORIUM	PROJECT NO: GCH/R-01A-101	PROJECT NO: 01